


DIMENSIONS FOR OVERALL HEIGHT AND LENGTH ARE APPROXIMATE
 OVERALL HEIGHT = 113"
 OVERALL WIDTH WITH RUB
 RAILS & FENDERETTES = 98"

PROAIR 206 DUAL COIL/DUAL PORT AC CONDENSER
 WITH WHELEN 700 WHITE SUPER LED MOUNTED ON FRONT

(2) TECNIQ S330 AMBER
 MINI-LED MARKER LIGHTS

(2) WHELEN 900 RED
 SUPER LED LIGHTS
 WITH CLEAR LENSES

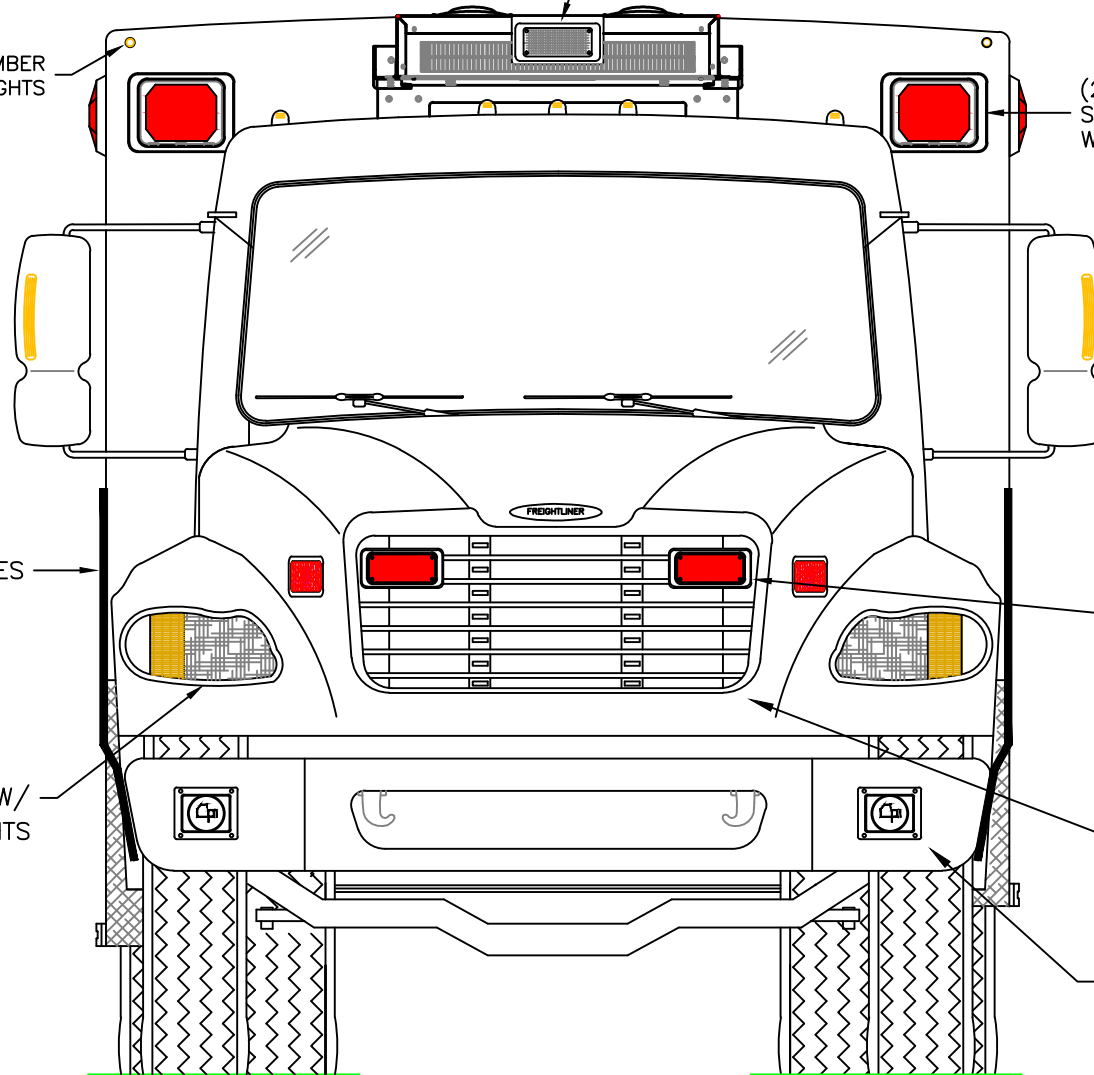

(2) WHELEN 700
 RED SUPER LED
 GRILLE LIGHTS
 WITH CLEAR LENSES

HIDDEN UNLOCK SWITCH
 IN GRILLE AREA

(2) CAST PRODUCTS
 100 WATT SIREN SPEAKERS
 RECESSED INTO BUMPER

LIGHTED BUMPER POLES

FLASHING HEADLIGHTS W/
 DAYTIME RUNNING LIGHTS

THIS DRAWING IS FOR REPRESENTATIONAL PURPOSES ONLY. DETAILS ARE CONCEPTUAL AND ARE SUBJECT TO CHANGE DURING DESIGN AND CONSTRUCTION
 DIMENSIONS ARE APPROXIMATE UNLESS NOTED OTHERWISE TO MEET A SPECIFIC CUSTOMER NEED.

TOTAL LIFE CARE
 CRITICAL CARE TRANSPORT




2020 FRONT EXTERIOR VIEW-BRAUN TOTAL LIFE CARE
 FREIGHTLINER M2 CREW CAB CHASSIS

DATE: 01-01-20
 DWG: GLF
 REV: NR
 DATE:

DRAWING NO.
 TLC-1

APPROVAL SIGNATURE:

DIMENSIONS FOR OVERALL HEIGHT AND LENGTH ARE APPROXIMATE
 OVERALL HEIGHT = 113"
 OVERALL WIDTH WITH RUB
 RAILS & FENDERETTES = 98"

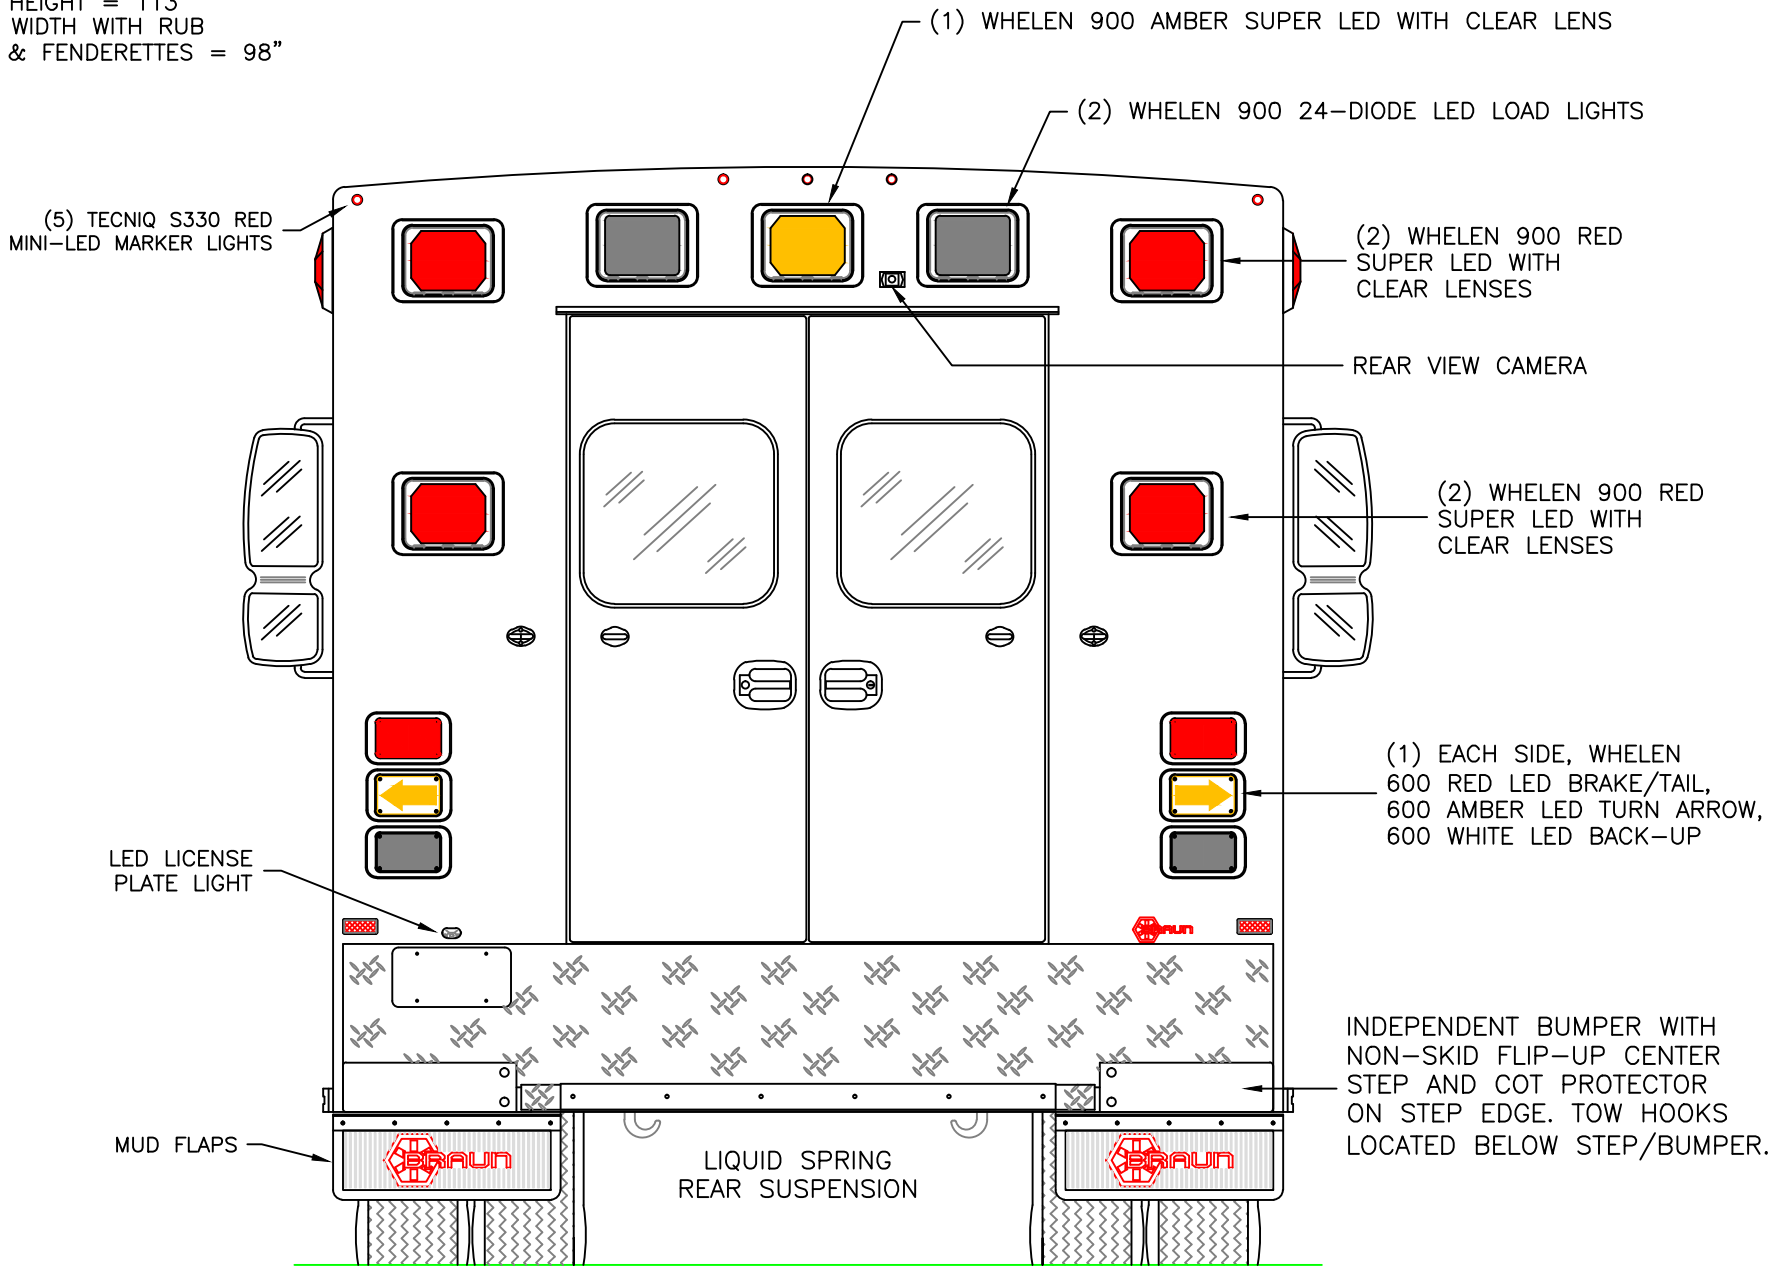

THIS DRAWING IS FOR REPRESENTATIONAL PURPOSES ONLY. DETAILS ARE CONCEPTUAL AND ARE SUBJECT TO CHANGE DURING DESIGN AND CONSTRUCTION
 DIMENSIONS ARE APPROXIMATE UNLESS NOTED OTHERWISE TO MEET A SPECIFIC CUSTOMER NEED.

TOTAL LIFE CARE
 CRITICAL CARE TRANSPORT




2020 REAR EXTERIOR VIEW-BRAUN TOTAL LIFE CARE
 FREIGHTLINER M2 CREW CAB CHASSIS

DATE:	01-01-20
DWG.:	GLF
REV.:	NR

DRAWING NO.
 TLC-2

DIMENSIONS FOR OVERALL HEIGHT AND LENGTH ARE APPROXIMATE

OVERALL HEIGHT = 113"
 OVERALL LENGTH = 360.25" (ESTIMATED)
 MODULE LENGTH = 191"
 CAB-TO-AXLE SHOWN = 122"
 WHEELBASE SHOWN = 234"

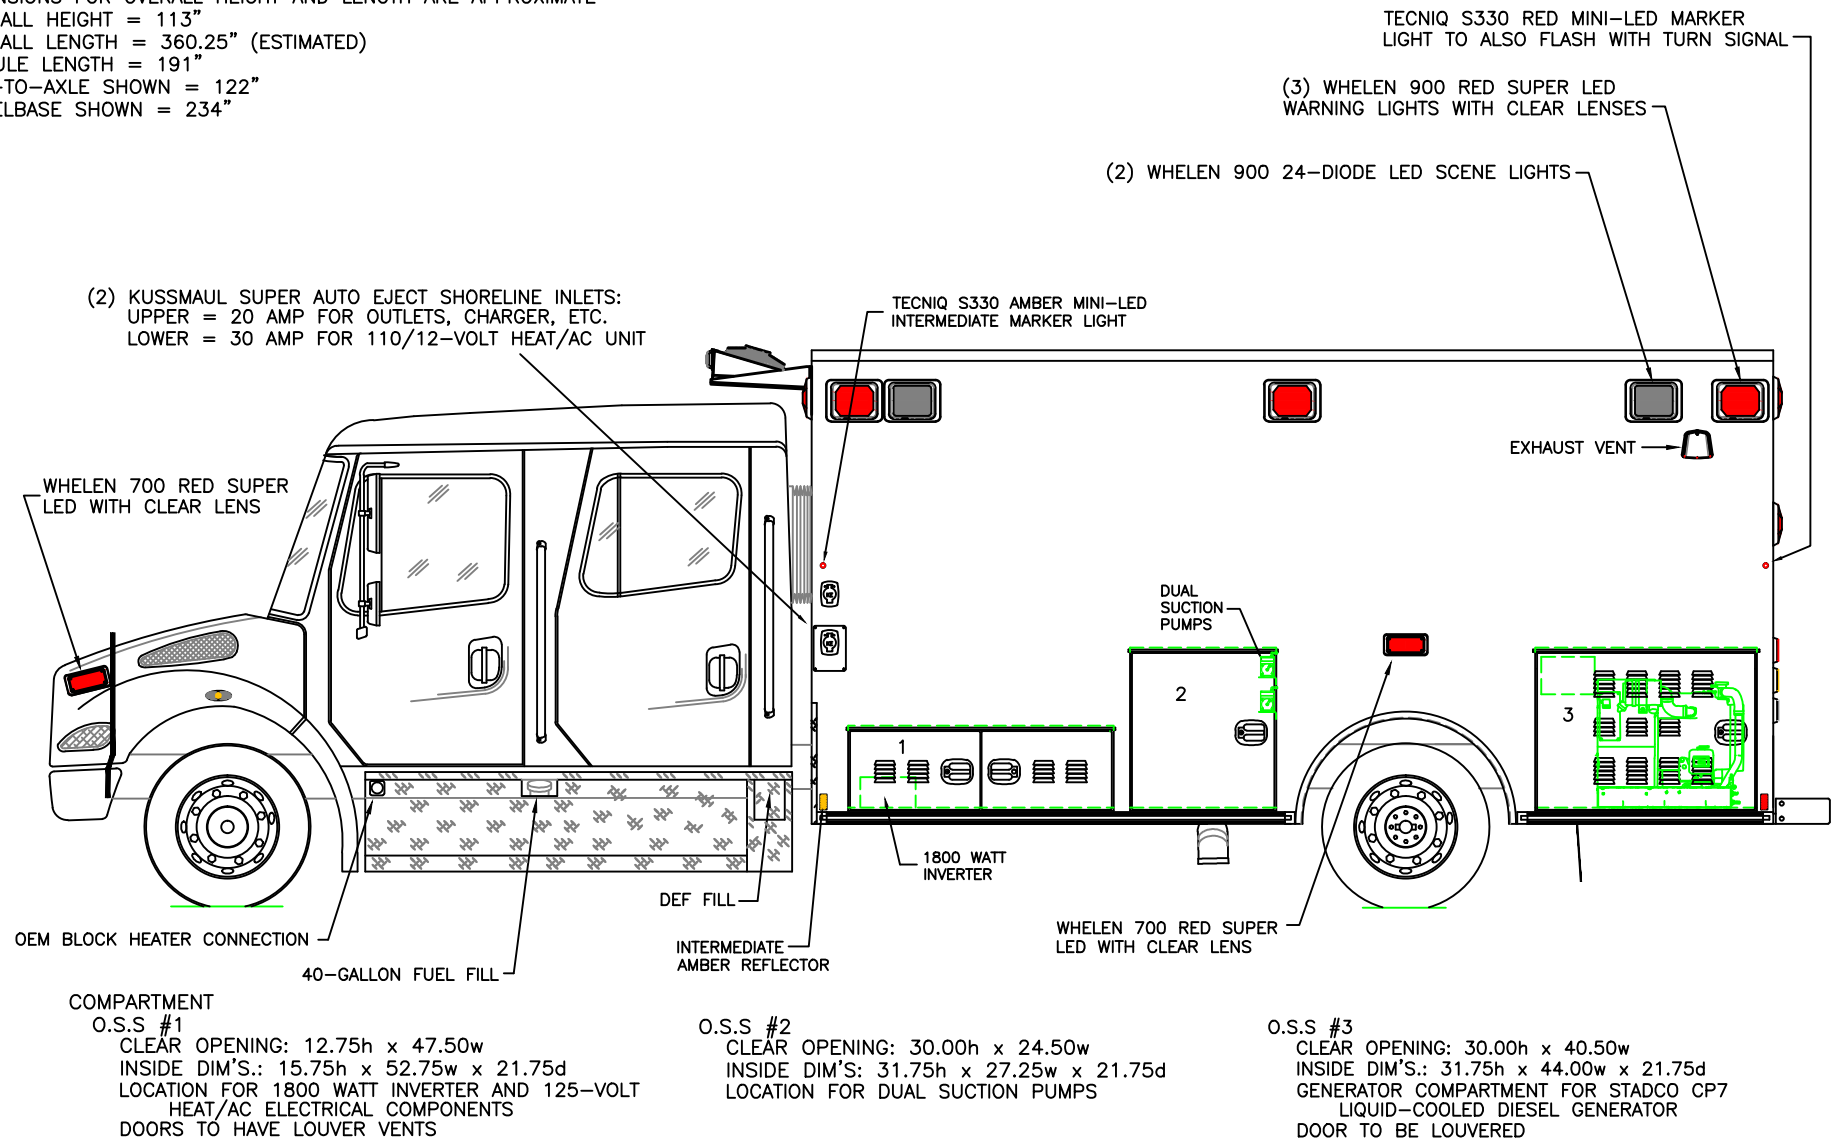

THIS DRAWING IS FOR REPRESENTATIONAL PURPOSES ONLY. DETAILS ARE CONCEPTUAL AND ARE SUBJECT TO CHANGE DURING DESIGN AND CONSTRUCTION
 DIMENSIONS ARE APPROXIMATE UNLESS NOTED OTHERWISE TO MEET A SPECIFIC CUSTOMER NEED.


TOTAL LIFE CARE
 CRITICAL CARE TRANSPORT



2020 STREETSIDE EXTERIOR VIEW-BRAUN TOTAL LIFE CARE
 FREIGHTLINER M2 CREW CAB CHASSIS

DATE:	01-01-20
DWG.:	GLF
REV:	NR

DRAWING NO.
 TLC-3

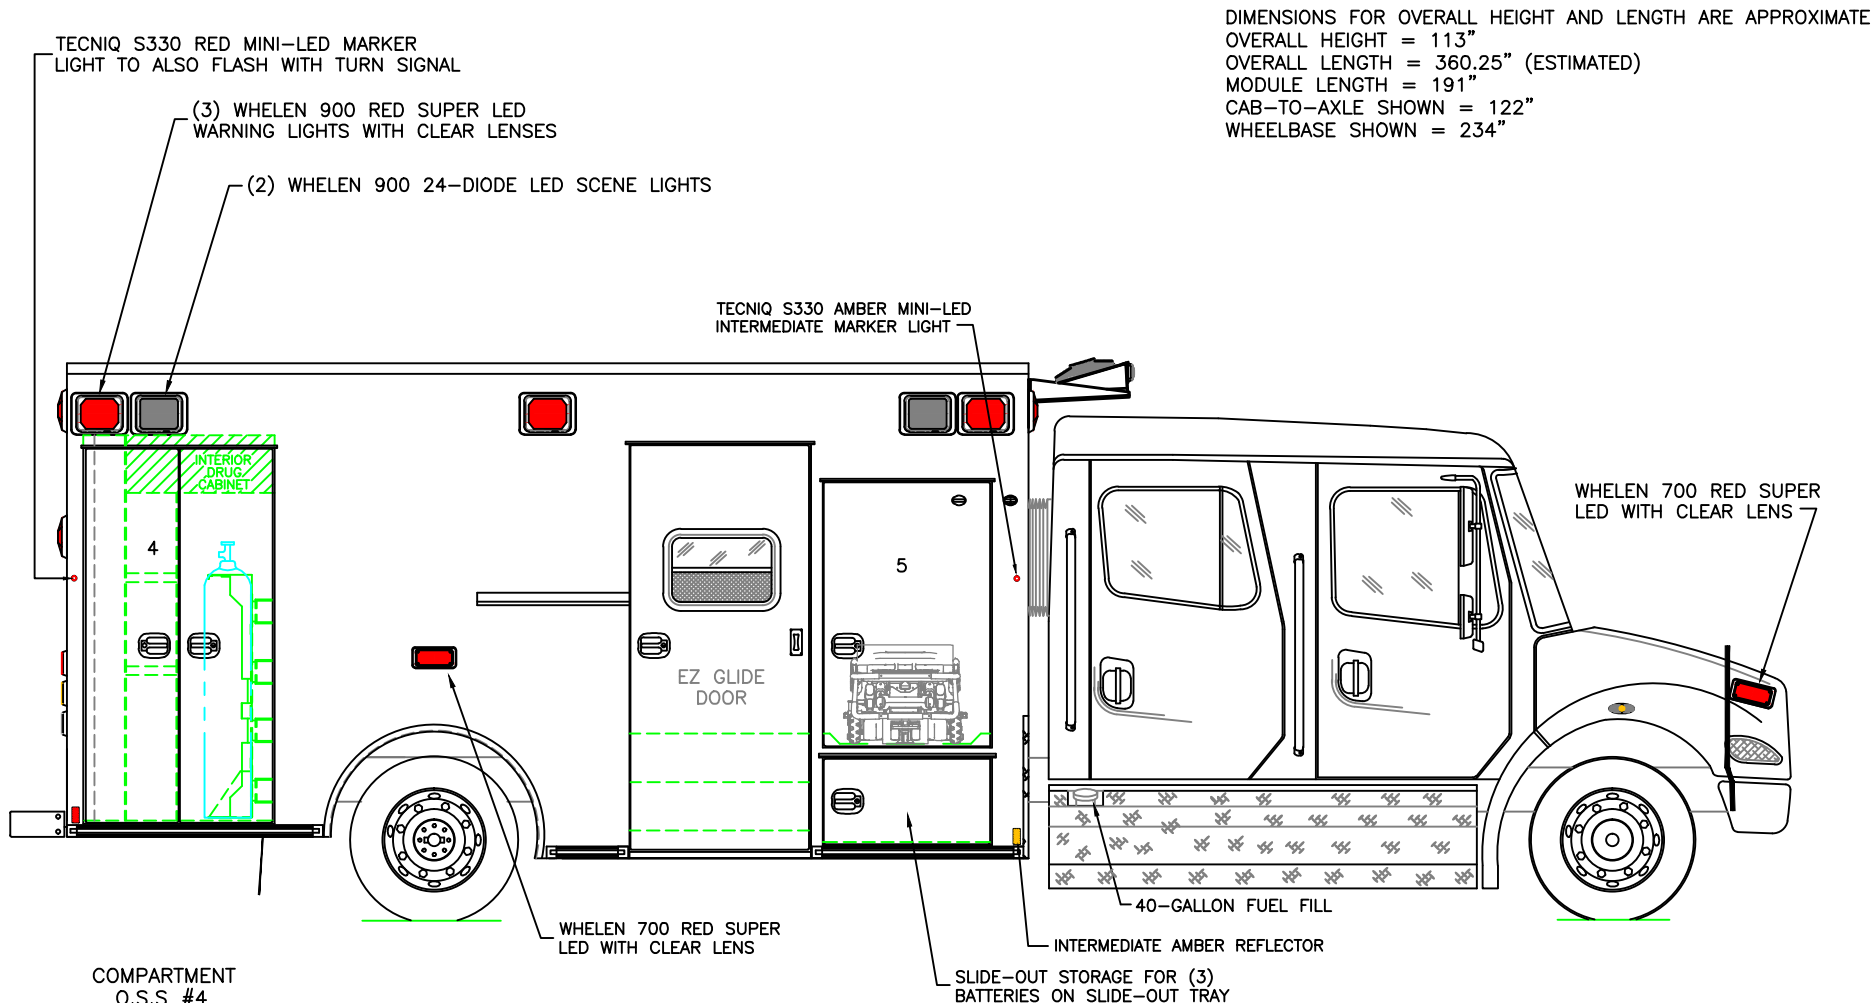


DIMENSIONS FOR OVERALL HEIGHT AND LENGTH ARE APPROXIMATE
 OVERALL HEIGHT = 113"
 OVERALL LENGTH = 360.25" (ESTIMATED)
 MODULE LENGTH = 191"
 CAB-TO-AXLE SHOWN = 122"
 WHEELBASE SHOWN = 234"

COMPARTMENT
 O.S.S #4
 CLEAR OPENING: 73.00h x 34.00w
 INSIDE DIM'S: 39.25w x 21.75d
 FIXED DIVIDER 29.75" FROM RIGHT WALL TO PROVIDE
 76.50h STORAGE FOR (2) BACKBOARDS ON LEFT
 SIDE OF DIVIDER
 INTERIOR HEIGHT 65.00h ON RIGHT SIDE OF DIVIDER
 DUE TO INTERIOR DRUG CABINET, UPPER AREA
 SECOND FIXED DIVIDER SPACED 10" ON RIGHT SIDE
 OF BACKBOARD DIVIDER, WITH (2) ADJUSTABLE SHELVES
 SLIDE-OUT "H" MEDICAL AIR AND OXYGEN TANKS WITH
 ZICO QR-MV BRACKETS TOWARDS RIGHT WALL

O.S.S #5
 CLEAR OPENING: 51.75h x 30.00w
 SIDE ENTRY FOR STRYKER PERFORMANCE LOAD, OR POWER LOAD COT
 SYSTEM WITH RECESSED FLOOR TO REACH REQUIRED COT LOAD HEIGHT.

THIS DRAWING IS FOR REPRESENTATIONAL PURPOSES ONLY. DETAILS ARE CONCEPTUAL AND ARE SUBJECT TO CHANGE DURING DESIGN AND CONSTRUCTION
 DIMENSIONS ARE APPROXIMATE UNLESS NOTED OTHERWISE TO MEET A SPECIFIC CUSTOMER NEED.



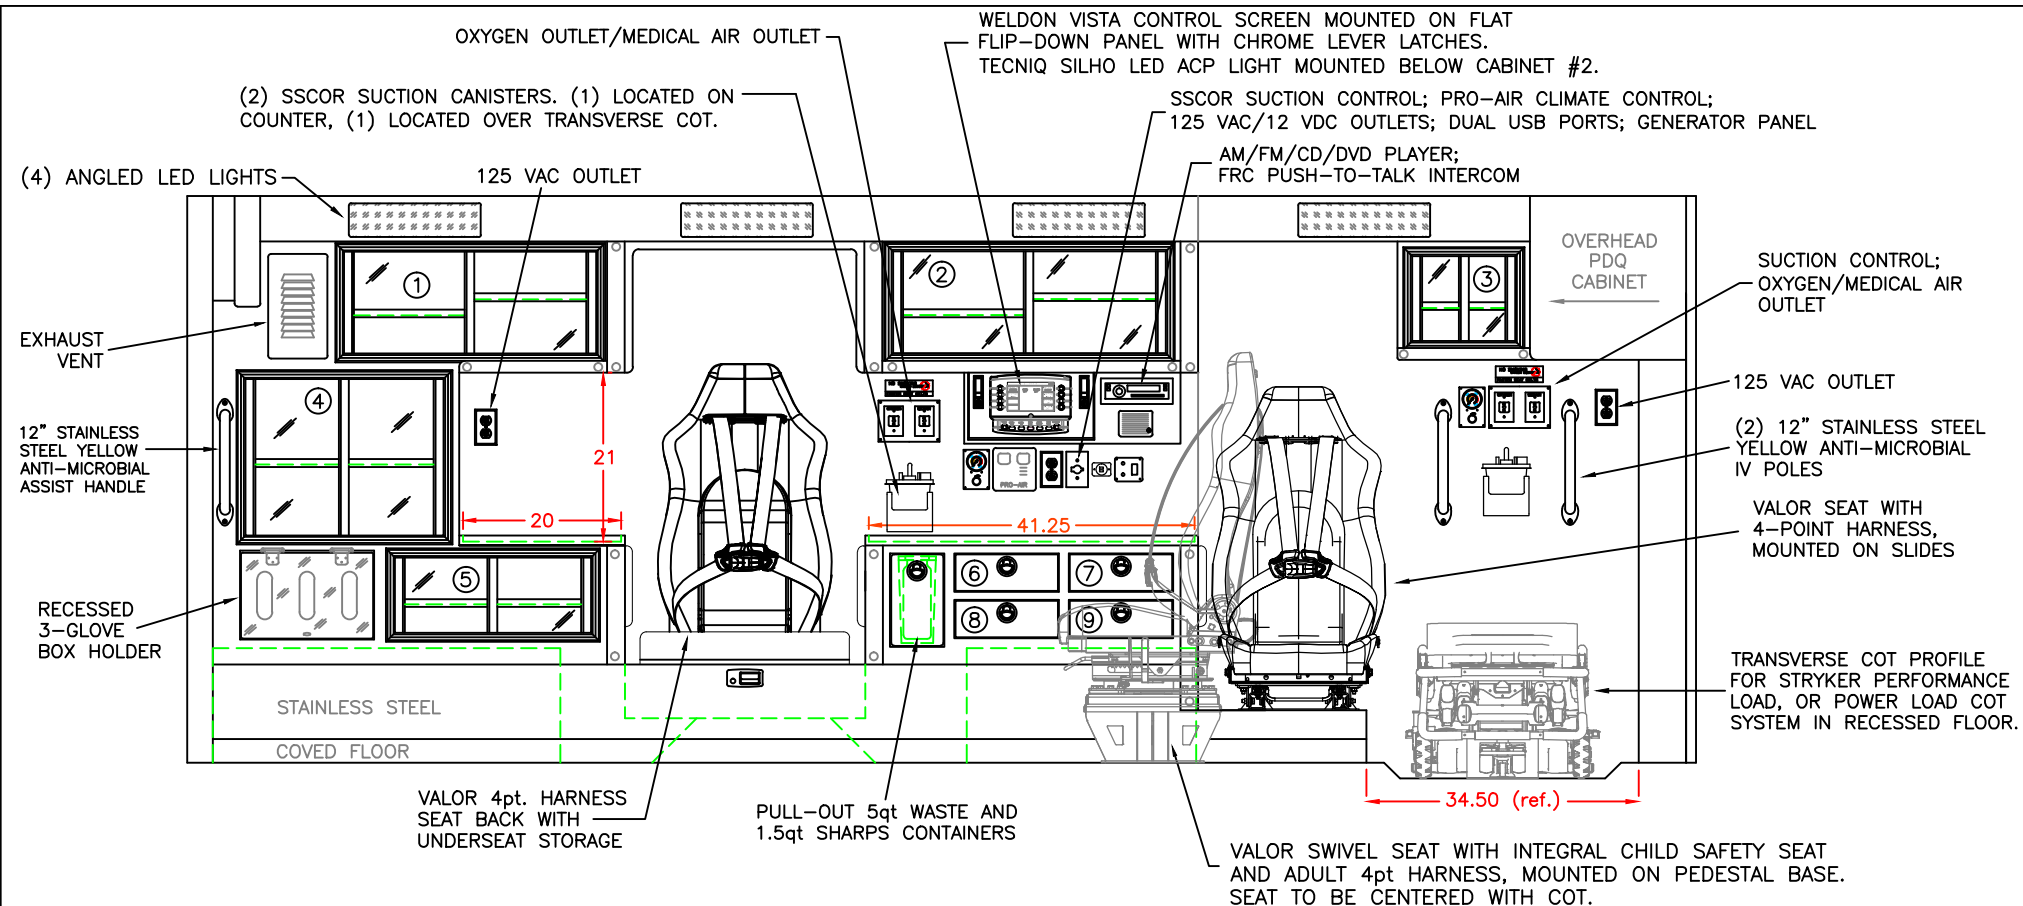

COMPARTMENT

#1 DOOR OPENING: 13.00h x 32.00w
 INSIDE DIMS: 14.75h x 33.75w x 19.50d
 (1) ADJ SHELF EACH SIDE OF CENTER DIVIDER
 SLIDING POLYCARBONATE DOORS
 TOTAL CABINET WEIGHT RATING = 25 lbs.

#2 DOOR OPENING: 13.00h x 34.50w
 INSIDE DIMS: 14.75h x 36.25w x 19.50d
 (1) ADJ SHELF EACH SIDE OF CENTER DIVIDER
 SLIDING POLYCARBONATE DOORS
 TOTAL CABINET WEIGHT RATING = 25 lbs.

#3 DOOR OPENING: 10.75h x 13.00w
 INSIDE DIMS: 12.50h x 14.75w x 6.00d
 (1) ADJUSTABLE SHELF
 SLIDING POLYCARBONATE DOORS
 TOTAL CABINET WEIGHT RATING = 15 lbs.
 NOTE: HEADLINER SECTION OVER CABINET #3 IS SET BACK DUE TO SHALLOW CABINET.

#4 DOOR OPENING: 18.75h x 25.00w
 INSIDE DIMS: 20.50h x 26.75w x 19.50d
 (1) ADJUSTABLE SHELF
 SLIDING POLYCARBONATE DOORS
 TOTAL CABINET WEIGHT RATING = 25 lbs.

#5 DOOR OPENING: 10.75h x 24.75w
 INSIDE DIMS: 12.50h x 26.50w x 19.50d
 (1) ADJUSTABLE SHELF
 SLIDING POLYCARBONATE DOORS
 TOTAL CABINET WEIGHT RATING = 15 lbs.

#6, #7, #8, & #9 PULL-OUT DRAWERS
 INSIDE DIMS: 4.00h x 11.00w x 15.00d
 LOCKING STAINLESS STEEL FLUSH PULL LATCHES
 TOTAL DRAWER WEIGHT RATING = 10 lbs. EACH

SOLID ACRYLIC COUNTERTOPS
 CABINETS TO BE ALUMINUM


THIS DRAWING IS FOR REPRESENTATIONAL PURPOSES ONLY. DETAILS ARE CONCEPTUAL AND ARE SUBJECT TO CHANGE DURING DESIGN AND CONSTRUCTION
 DIMENSIONS ARE APPROXIMATE UNLESS NOTED OTHERWISE TO MEET A SPECIFIC CUSTOMER NEED.

TOTAL LIFE CARE
 CRITICAL CARE TRANSPORT



2020 STREETSIDE INTERIOR VIEW
 BRAUN TOTAL LIFE CARE

DATE:	01-01-20		DRAWING NO.
DWG.	GLF	REV.	NR
			TLC-5

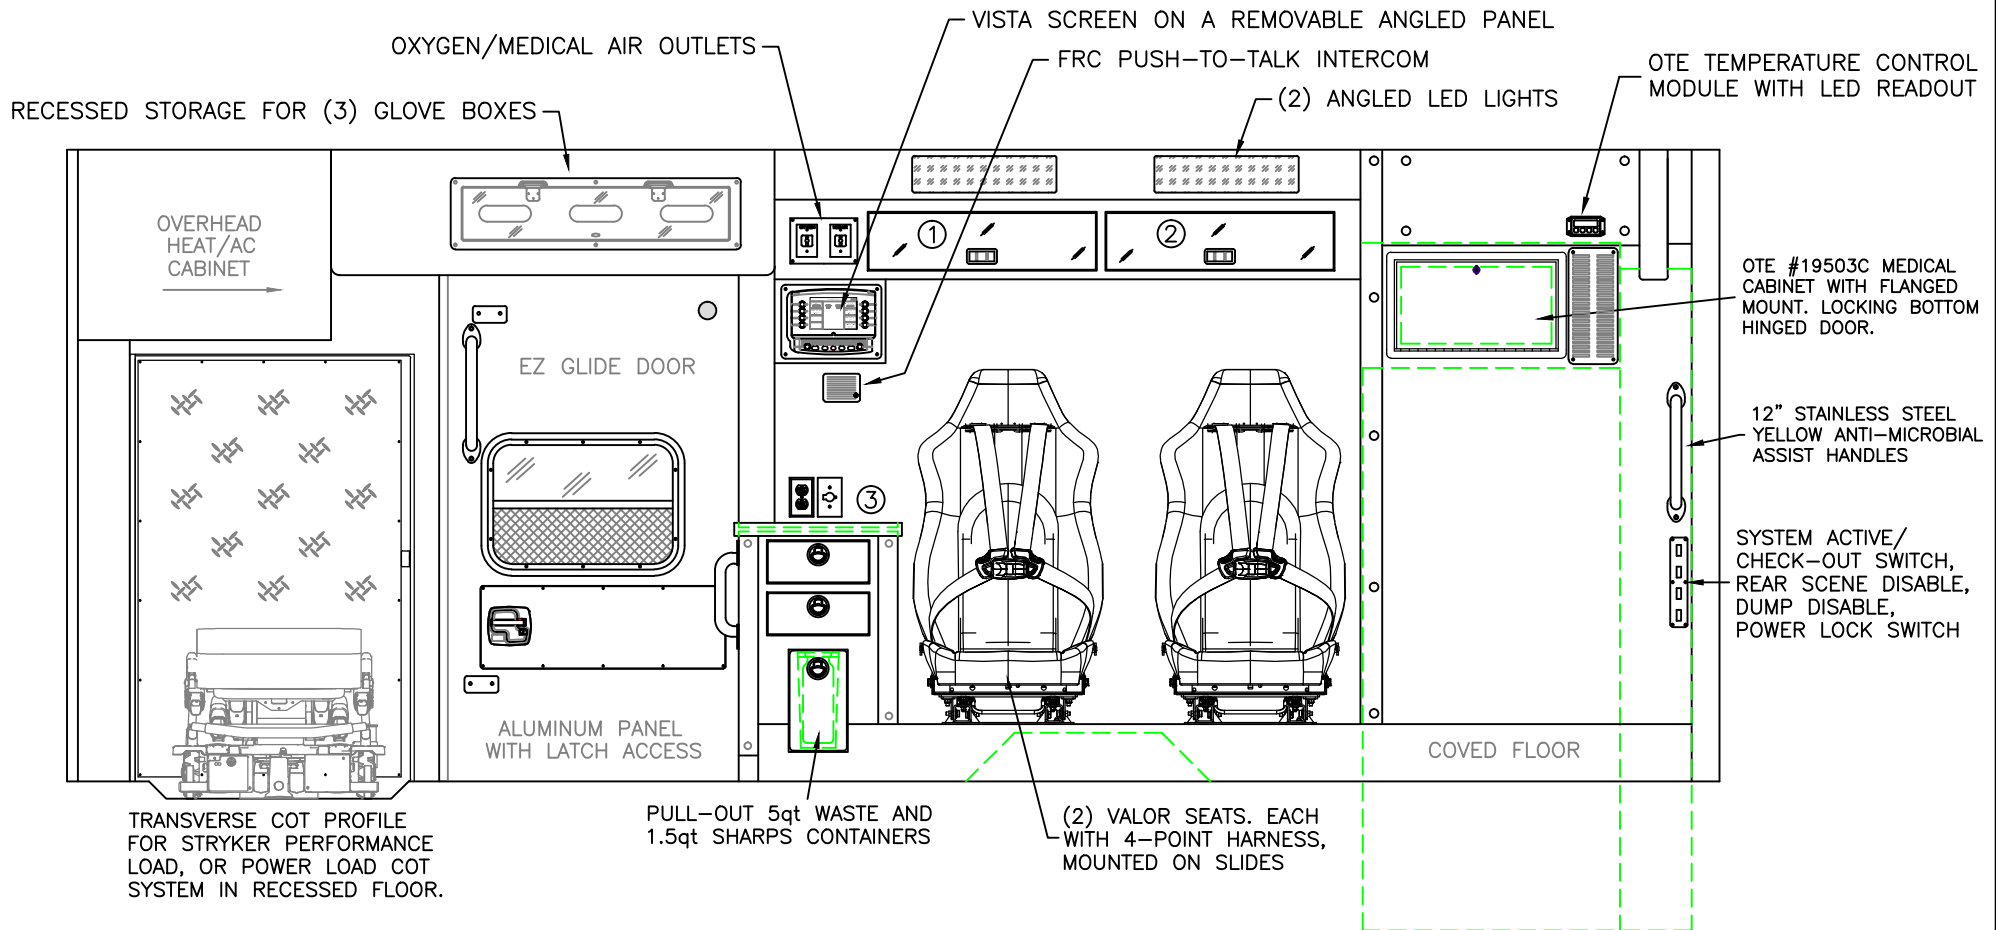

COMPARTMENT

#1 & #2 DOOR OPENINGS: 6.75h x 26.50w
 INSIDE DIMS: 6.75h x 26.50w x 6.00d
 TOP HINGED ACRYLIC CABINET DOORS WITH CENTER SQUEEZE LATCHES
 TOTAL CABINET WEIGHT RATING = 10 lbs. EACH

#3 CABINET WITH SOLID ACRYLIC COUNTERTOP
 (2) PULL-OUT STORAGE DRAWERS TOWARDS COT
 INSIDE DIMS: 4.00h x 10.00w x 13.00d
 PULL-OUT SHARPS/WASTE DRAWER TOWARD COT
 ALL HAVE LOCKING STAINLESS STEEL FLUSH PULL LATCHES
 125 VAC/12 VDC OUTLETS ABOVE COUNTERTOP
 TOTAL DRAWER WEIGHT RATING = 10 lbs. EACH

CABINETS TO BE ALUMINUM

THIS DRAWING IS FOR REPRESENTATIONAL PURPOSES ONLY. DETAILS ARE CONCEPTUAL AND ARE SUBJECT TO CHANGE DURING DESIGN AND CONSTRUCTION
 DIMENSIONS ARE APPROXIMATE UNLESS NOTED OTHERWISE TO MEET A SPECIFIC CUSTOMER NEED.

TOTAL LIFE CARE
 CRITICAL CARE TRANSPORT



2020 CURBSIDE INTERIOR VIEW
 BRAUN TOTAL LIFE CARE

DATE:	01-01-20	DRAWING NO.	
DWG.	GLF	REV.	NR
			TLC-6

ANGLED OF FORWARD HEADLINER THAT IS SET BACK


CABINET PROFILE OVER FORWARD SEAT

PROAIR IW-5556
110/12-VOLT HEAT/AC SYSTEM. 110-VOLT SYSTEM TO BE ABLE TO OPERATE WITH SHORELINE OR GENERATOR.

THIS WALL SECTION IS DEEPER THAN STANDARD TO ALLOW FOR HEAT/AC HOSE ROUTING, ETC.

TRANSVERSE COT PROFILE FOR STRYKER PERFORMANCE LOAD, OR POWER LOAD COT SYSTEM IN RECESSED FLOOR.

(2) TECNIQ SILHO-X LED LIGHTS MOUNTED BELOW CABINETS. TO COME ON WITH CEILING DOME LIGHTS.

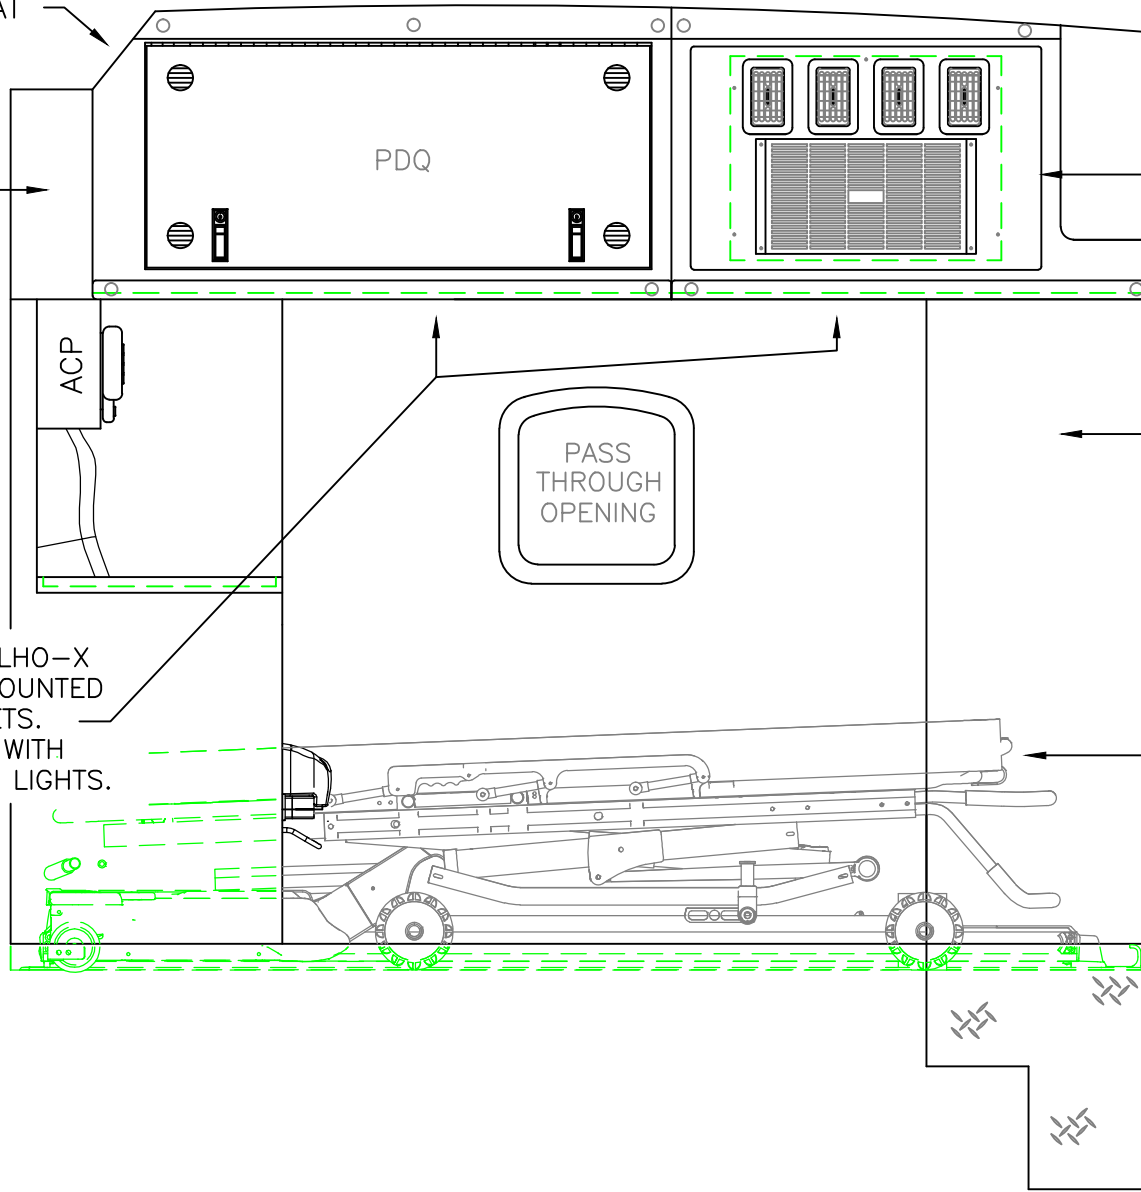

CABINETS TO BE ALUMINUM


THIS DRAWING IS FOR REPRESENTATIONAL PURPOSES ONLY. DETAILS ARE CONCEPTUAL AND ARE SUBJECT TO CHANGE DURING DESIGN AND CONSTRUCTION DIMENSIONS ARE APPROXIMATE UNLESS NOTED OTHERWISE TO MEET A SPECIFIC CUSTOMER NEED.

TOTAL LIFE CARE
CRITICAL CARE TRANSPORT



2020 PARTITION INTERIOR VIEW
BRAUN TOTAL LIFE CARE

DATE:		DRAWING NO.	
01-01-20		TLC-7	
DWG.	REV.		
GLF	NR		

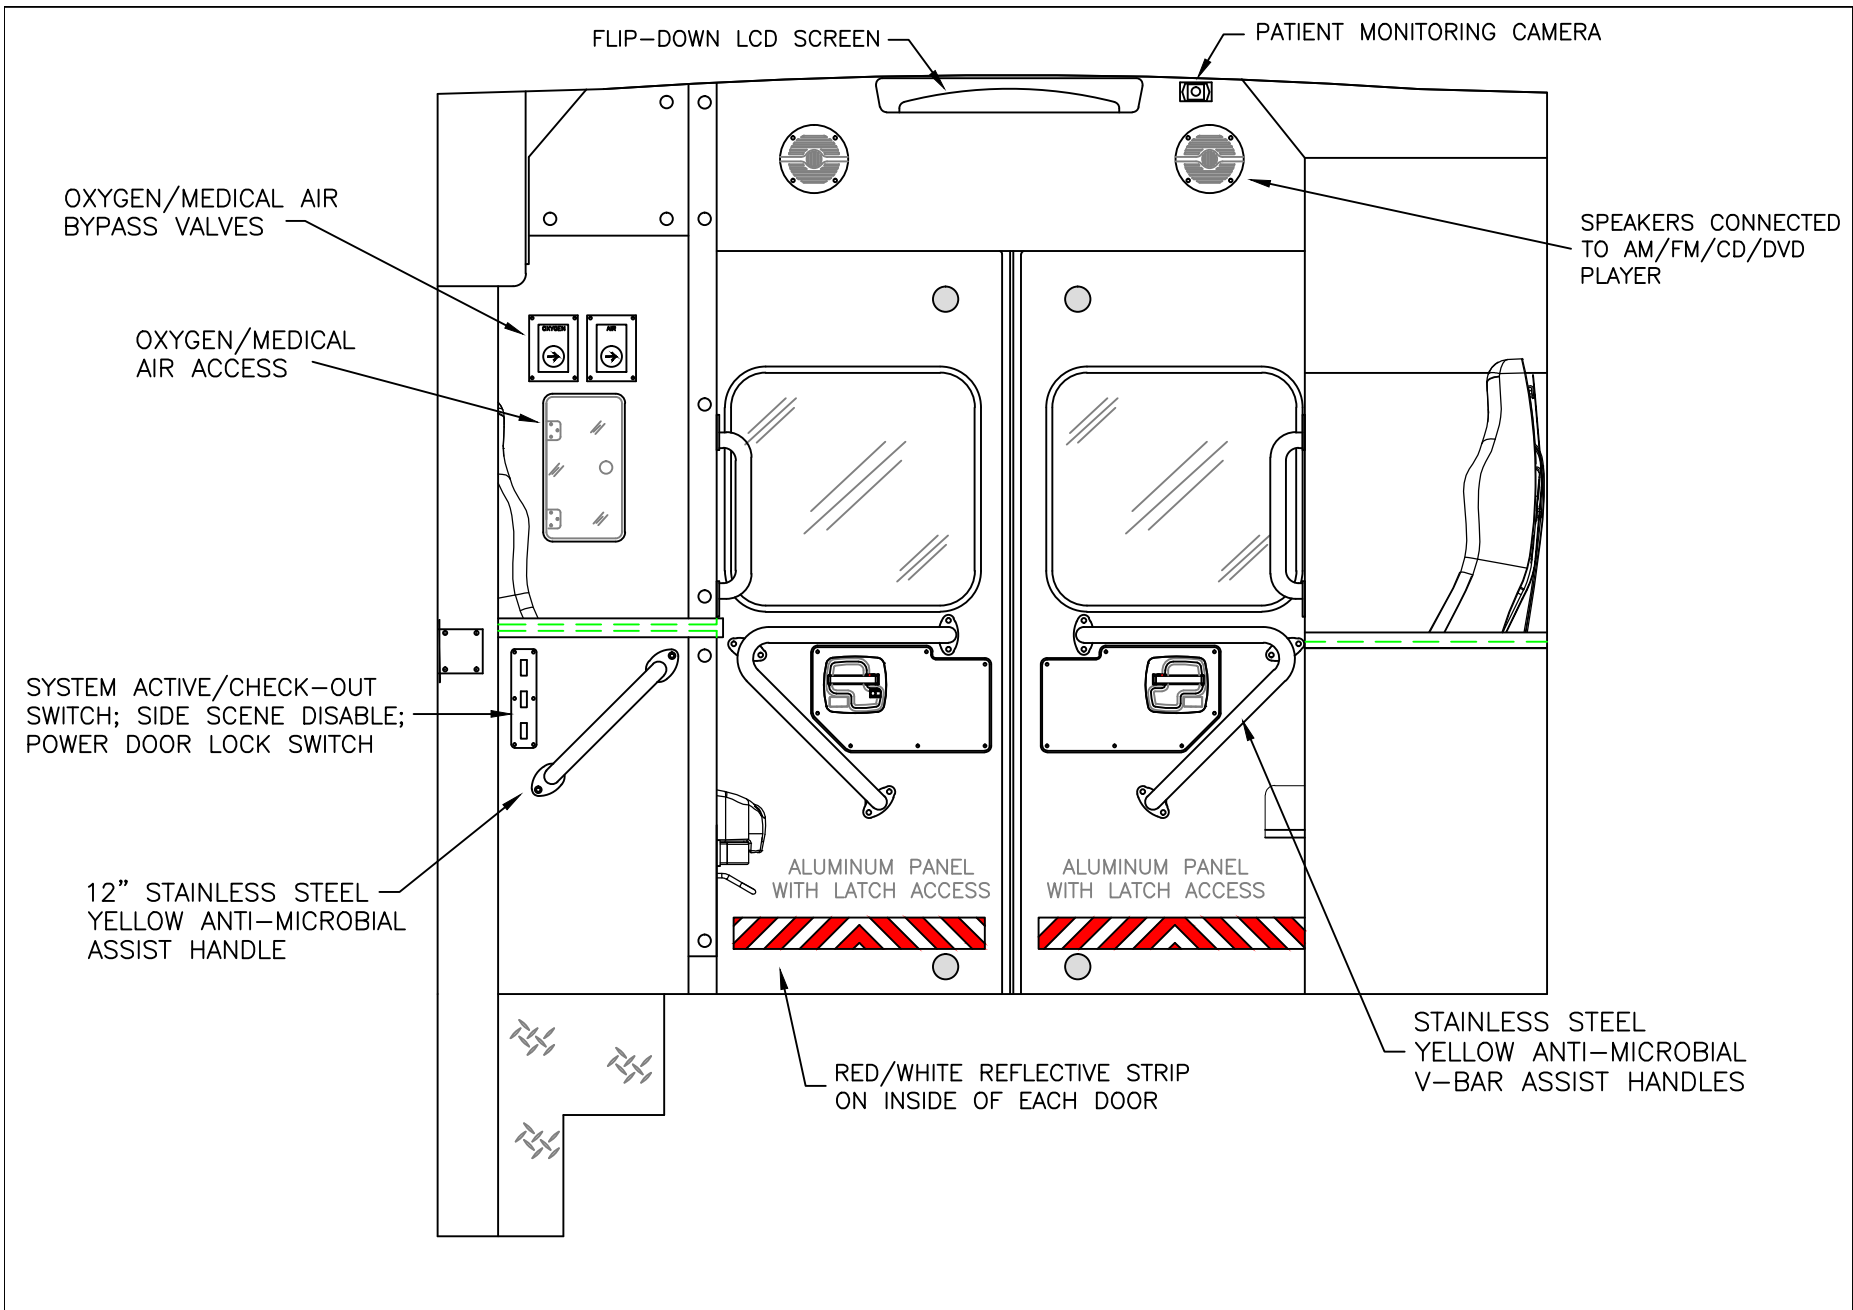

THIS DRAWING IS FOR REPRESENTATIONAL PURPOSES ONLY. DETAILS ARE CONCEPTUAL AND ARE SUBJECT TO CHANGE DURING DESIGN AND CONSTRUCTION DIMENSIONS ARE APPROXIMATE UNLESS NOTED OTHERWISE TO MEET A SPECIFIC CUSTOMER NEED.


TOTAL LIFE CARE
CRITICAL CARE TRANSPORT



2020 REAR INTERIOR VIEW
BRAUN TOTAL LIFE CARE

DATE:	01-01-20
DWG.	REV.
GLF	NR

DRAWING NO.	TLC-8
-------------	-------

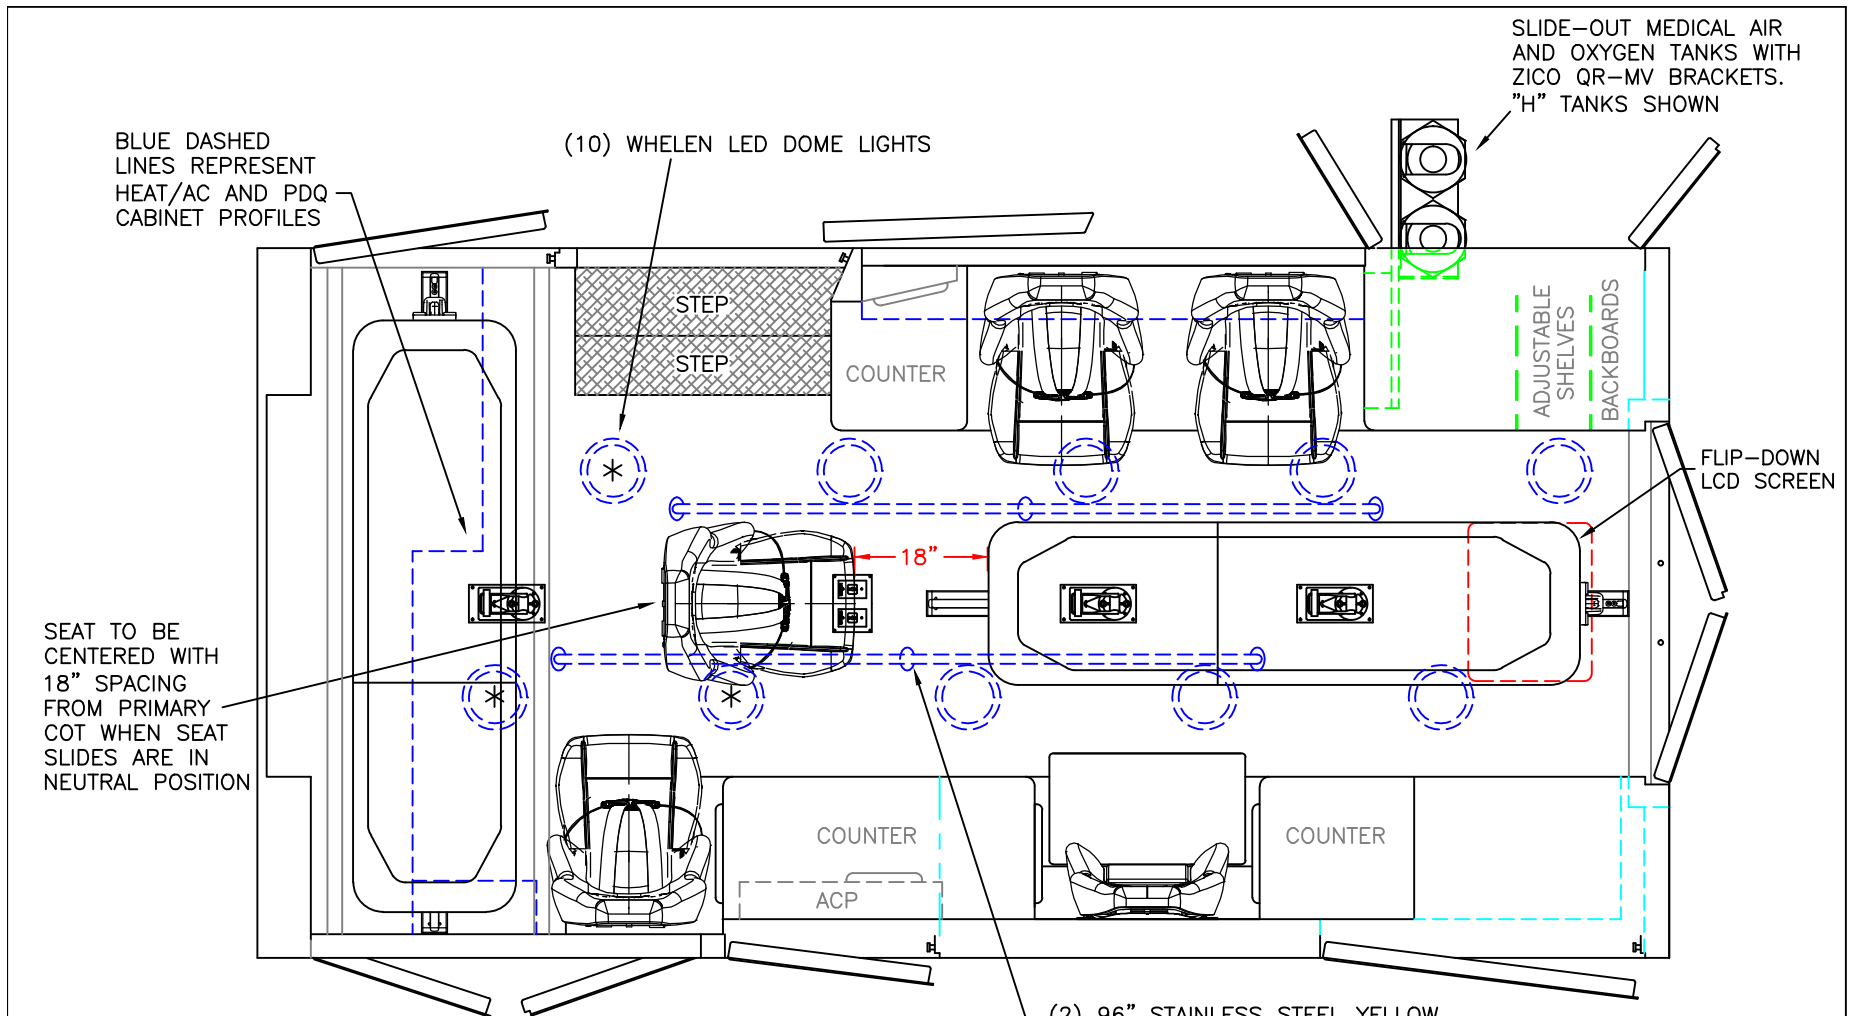


SLIDE-OUT MEDICAL AIR AND OXYGEN TANKS WITH ZICO QR-MV BRACKETS. "H" TANKS SHOWN

BLUE DASHED LINES REPRESENT HEAT/AC AND PDQ CABINET PROFILES

(10) WHELEN LED DOME LIGHTS

SEAT TO BE CENTERED WITH 18" SPACING FROM PRIMARY COT WHEN SEAT SLIDES ARE IN NEUTRAL POSITION

 = (3) RECESSED CEILING IV HANGER LOCATIONS

 = (1) CEILING OXYGEN/MEDICAL AIR OUTLET

* = (2) RADIO ANTENNA BASES LOCATED OUTBOARD OF DOME LIGHTS WITH COAX SERVICE LOOP
 (1) AM/FM RADIO ANTENNA FOR PATIENT COMPARTMENT RADIO

(2) 96" STAINLESS STEEL YELLOW ANTI-MICROBIAL CEILING GRAB RAILS

MODULE WIDTH = 96"
 MODULE LENGTH = 191"
 MODULE HEAD ROOM = 73.5"

STRYKER PERFORMANCE LOAD CENTER MOUNT COT HARDWARE, LOAD THROUGH REAR DOORWAY
 ADDITIONAL STRYKER PERFORMANCE LOAD IN THE TRANSVERSE POSITION, LOAD THROUGH SIDE DOOR
 IN RECESSED FLOOR (RECESSED FLOOR TO ALSO ACCOMODATE OPTIONAL POWER LOAD COT SYSTEM)

THIS DRAWING IS FOR REPRESENTATIONAL PURPOSES ONLY. DETAILS ARE CONCEPTUAL AND ARE SUBJECT TO CHANGE DURING DESIGN AND CONSTRUCTION
 DIMENSIONS ARE APPROXIMATE UNLESS NOTED OTHERWISE TO MEET A SPECIFIC CUSTOMER NEED.

TOTAL LIFE CARE
 CRITICAL CARE TRANSPORT



2020 FLOOR INTERIOR VIEW
 BRAUN TOTAL LIFE CARE

DATE:	01-01-20
DWG.	REV.
GLF	NR

DRAWING NO.	TLC-9
-------------	-------